



3825 NW 107TH AVENUE  
 MIAMI, FL 33176-2007  
 PHONE: 305.972.2275 FAX: 305.972.0339  
 FPC CERTIFICATE OF AUTHORIZATION NO. 24

CONSULTANT:



CITY OF MIAMI  
 CERTIFICATE OF AUTHORIZATION  
 NUMBER: 1239

CLIENT / PROJECT NAME:



CITY OF MIAMI  
 ROBERT KING HIGH PARK  
 SOCCER FIELD

703 W. FLORISS STREET, MIAMI, FLORIDA

GENERAL NOTES:


MARK	DATE	DESCRIPTION
1	11/2/10	ADDITIONAL
2		
3		
4		
5		
6		

PROFESSIONAL SEAL:  
 ARCHITECT OF RECORD:  
 CHARLES ALAYATO  
 REG. NO. 11796


SHEET TITLE:  
 FLOOR, REFLECTED  
 CEILING AND ROOF PLANS

DATE ISSUED:	SHEET NUMBER:
01/18/11	08/08/10
DESIGNED BY:	DRAWN BY:
LD	LD
CHECKED BY:	DATE:
LD	01/18/11
PROJECT:	LOCATION:
CA	CA


A101

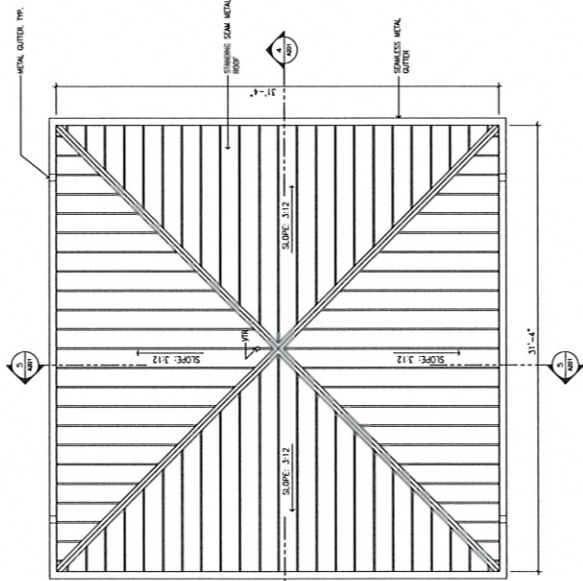


2 ROOF PLAN  
 A101 SCALE: 1/4" = 1'-0"

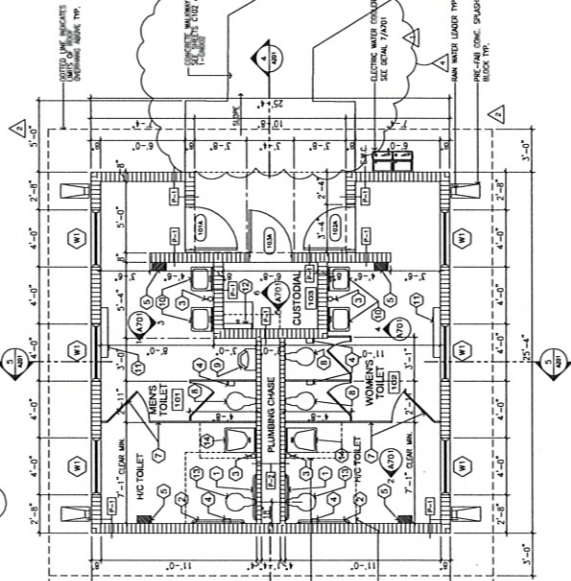

1 FLOOR PLAN  
 A101 SCALE: 1/8" = 1'-0" 3/4"

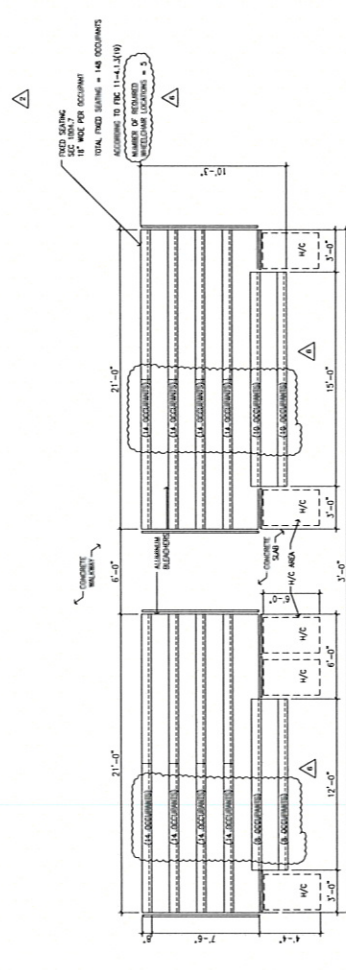

4 ENLARGED BLEACHERS PLAN  
 A101 SCALE: 1/4" = 1'-0"

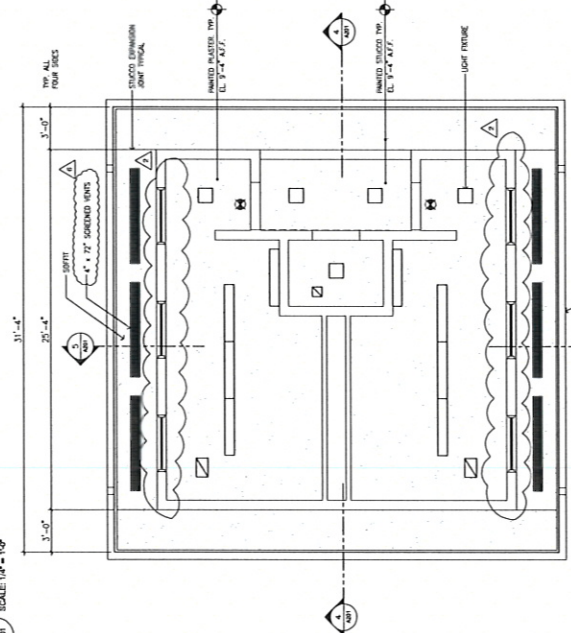

3 REFLECTED CEILING PLAN  
 A101 SCALE: 1/4" = 1'-0"

PLUMBING FIXTURES CALCULATIONS (ICC PLUMBING TABLE 403.1) (SEE TABLE 403.1)

WATER CLOSETS	LAVATORIES	BATHS/SHOWERS	DRINKING FOUNTAINS	SERVICE SINK
1 PER 75	1 PER 40	1 PER 100	1 PER 1,000	1
2	3	1	-	1
3	3	3	-	2

ADDITIONAL INFORMATION: ONE ACCESSIBLE INDOOR TOILET WITH 1 WATER CLOSET, 1 LAVATORY AND 1 SHOWER

LEGEND

SYMBOL	DESCRIPTION
[Symbol]	SURFACE MOUNTED INDUSTRIAL BATTERY OPERATED LIGHT
[Symbol]	RECESSED FLUORESCENT LIGHT
[Symbol]	A/C SUPPLY DIFFUSER
[Symbol]	EXHAUST GRILLE
[Symbol]	FLOOR MTD. HEAVY DUTY (U-1521)
[Symbol]	MIRROR - STAINLESS STEEL (B-1006)
[Symbol]	FLOOR MTD. HEAVY DUTY (U-1521)
[Symbol]	WALL MOUNTED WATER CLOSET
[Symbol]	WALL MOUNTED URINAL
[Symbol]	WALL MOUNTED LAVATORY
[Symbol]	SMART CHANGING TABLE (68-100-00)
[Symbol]	5.5. MIP & BRUSH HOLDER (B - 223 X 24)
[Symbol]	WALL MOUNTED WATER CLOSET - ADA
[Symbol]	WALL MOUNTED LAVATORY - ADA

RESTROOM ACCESSORIES

1	1" DIA. - 36" LONG S.S. GRAB BAR (B-5808 X 30)
2	1" DIA. - 48" LONG S.S. GRAB BAR (B-5808 X 42)
3	WALL MOUNTED SOAP DISPENSER (B-4112)
4	SURFACE MOUNTED TOILET PAPER DISPENSER (B-2888)
5	MIRROR - STAINLESS STEEL (B-1006)
6	FLOOR MTD. HEAVY DUTY (U-1521)
7	WALL MOUNTED WATER CLOSET
8	WALL MOUNTED URINAL
9	WALL MOUNTED LAVATORY
10	SMART CHANGING TABLE (68-100-00)
11	5.5. MIP & BRUSH HOLDER (B - 223 X 24)
12	WALL MOUNTED WATER CLOSET - ADA
13	WALL MOUNTED LAVATORY - ADA

NOTES:  
 1. ALL DIMENSIONS SHOWN ARE TAKEN FROM FACE TO FACE OF FIN.  
 2. STRUCTURAL STRENGTH FOR ALL GRAB BARS SHALL BE 250 LB/FT.